




HOUSEPLAN 2101-01  
1234 RUSTIC  
HOUSTON, TX 77087

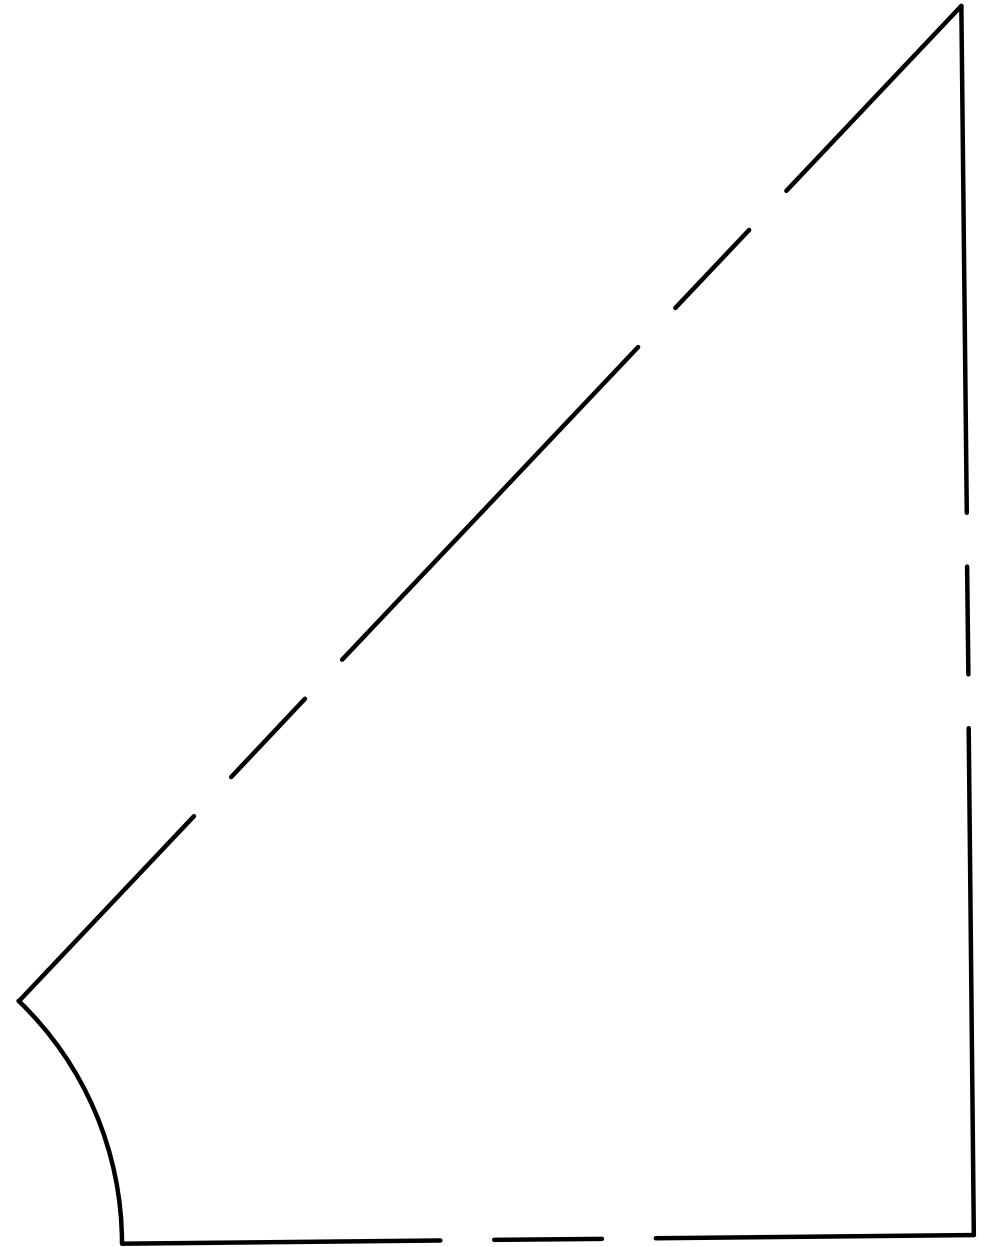

**1** Site Plan  
Scale: 3/32"=1'-0"

REVISIONS

DATE	DESCRIPTION

SEAL

DRAWING NAME:

Site Plan  
PLAN  
PLAN

DATE: 12/17/2017 SC: AS SHOWN


DRAWN: NN CHKD:

SHEET NUMBER

**A1-00**



HOUSEPLAN 2101-01  
1234 RUSTIC  
HOUSTON, TX 77087

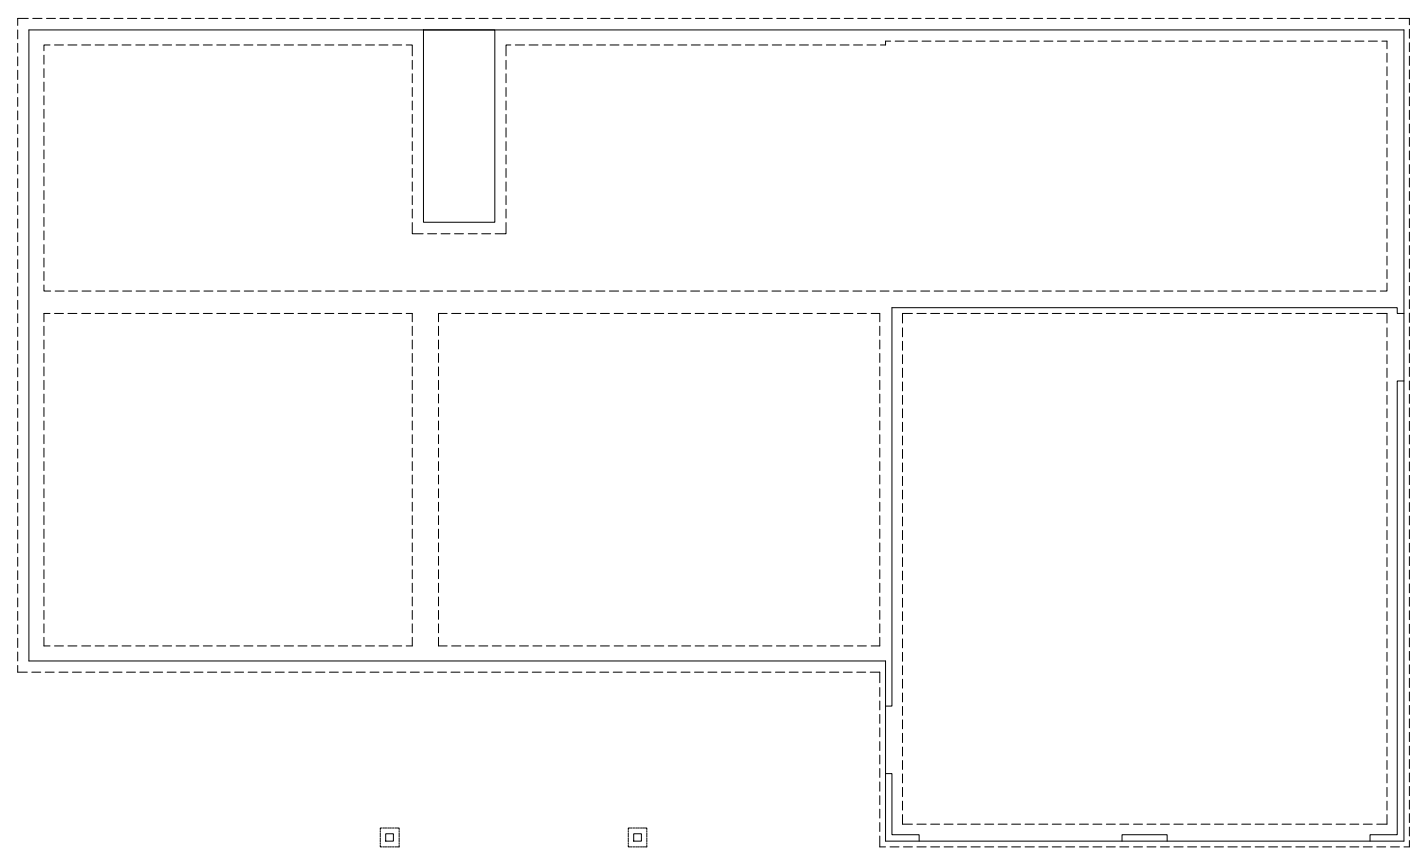

**1** Foundation Plan  
Scale: 1/8"=1'-0"


REVISIONS	
DATE	DESCRIPTION

SEAL


DRAWING NAME:  
**FOUNDATION**  
—  
—

DATE:12/17/2017	SC: AS SHOWN
DRAWN:NN	CHKD:

SHEET NUMBER  
**A1-1**

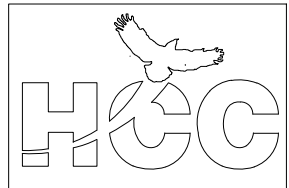

HOUSEPLAN 2101-01  
 1234 RUSTIC  
 HOUSTON, TX 77087

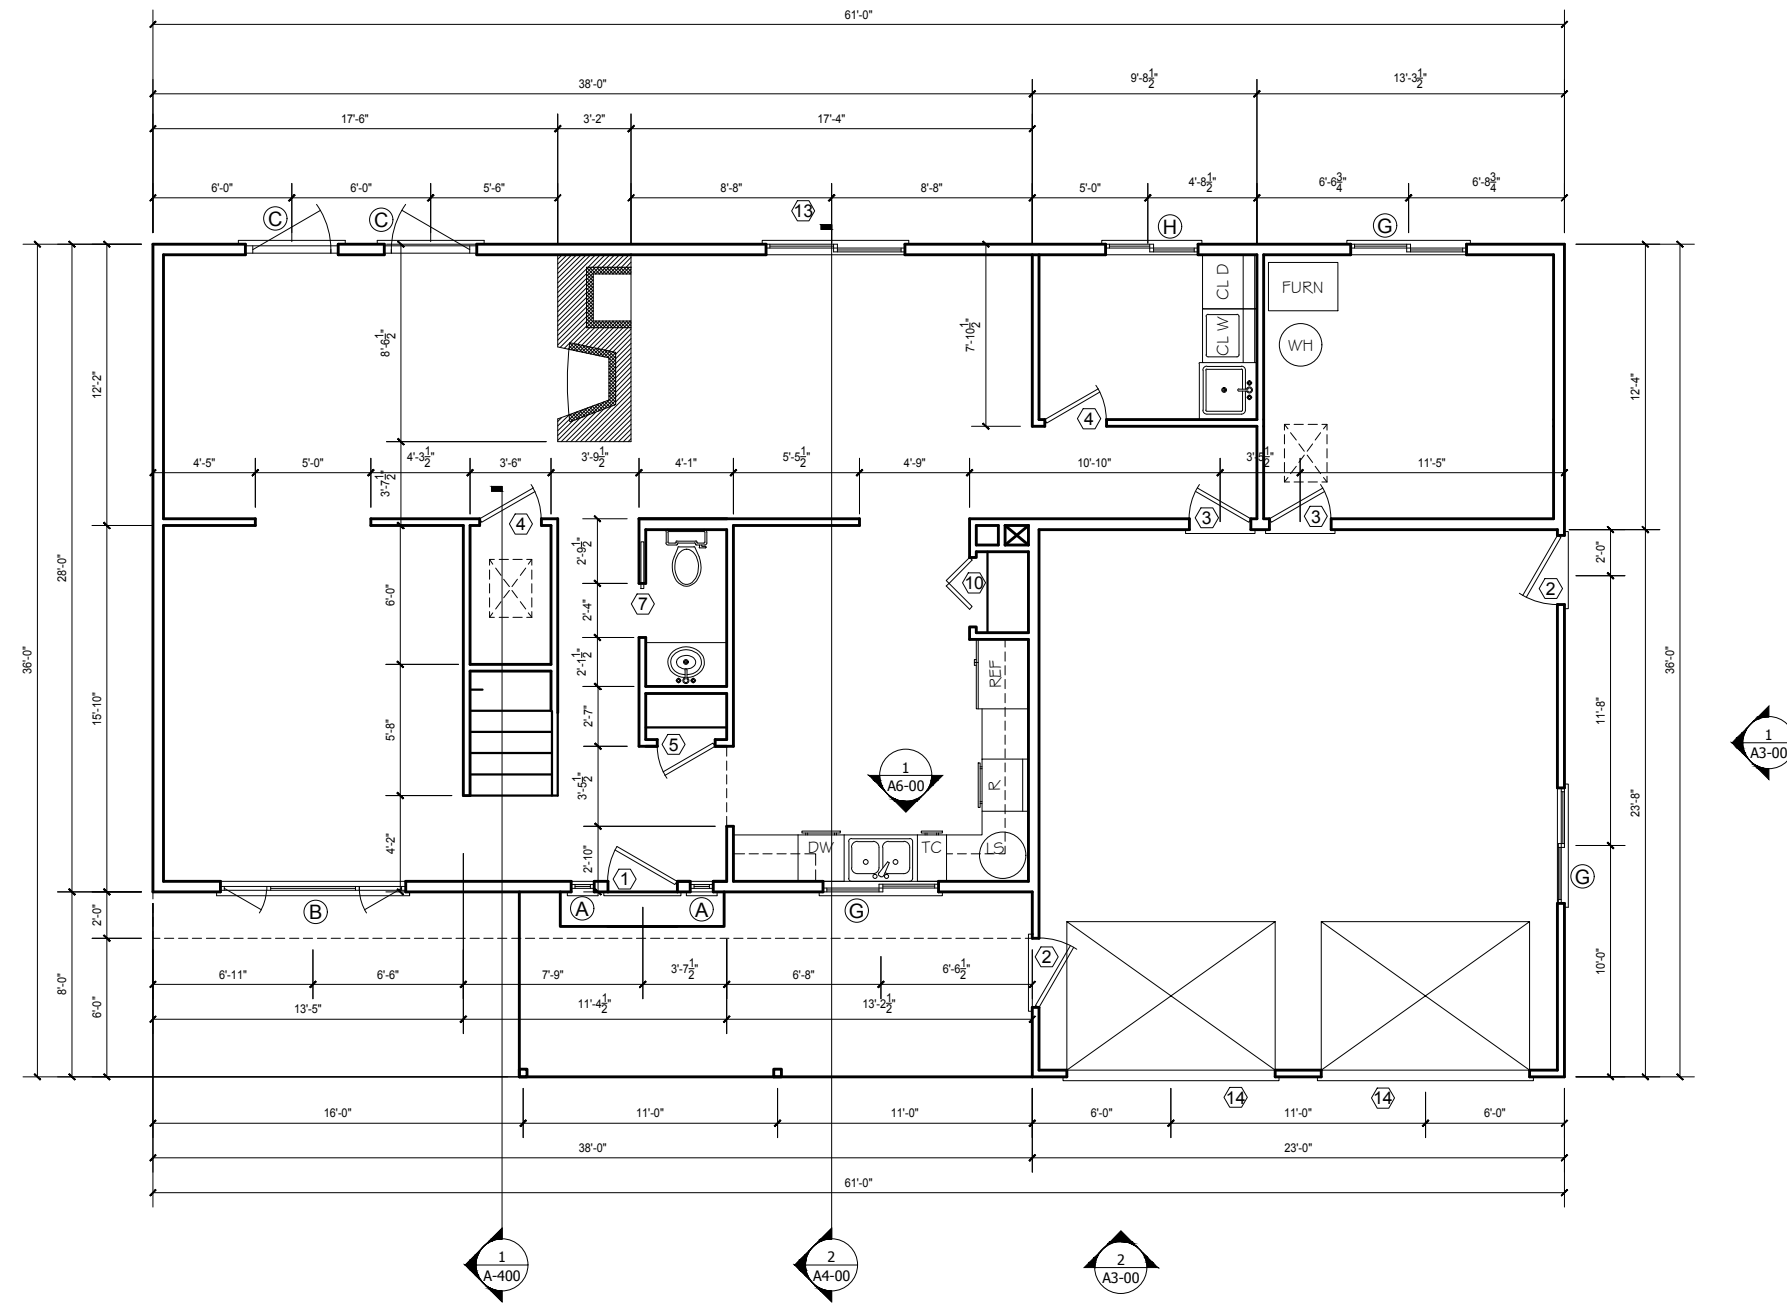

**1** First Floor Plan  
 Scale: 1/8"=1'-0"

REVISIONS	
DATE	DESCRIPTION

SEAL

DRAWING NAME:  
**FLOOR PLAN**

DATE: 12/17/2017	SC: AS SHOWN
DRAWN: NN	CHKD:


SHEET NUMBER  
**A2-00**



HOUSEPLAN 2101-01  
 1234 RUSTIC  
 HOUSTON, TX 77087

WINDOW SCHEDULE				
MARK	SIZE	TYPE	ROUGH	QUAN
A	1'-0" X 5'-0"	TEMPERED		2
B	8'-0" X 5'-0"	W4N5 CSM	8'-2 3/4" X 5'-5 7/8"	1
C	4'-0" X 5'-0"	W2N5 CMS	4'-2 1/4" X 5'-5 7/8"	2
D	4'-0" X 3'-6"	W2N3 CMS	4'-2 1/4" X 3'-5 1/2"	2
E	3'-6" X 3'-6"	2N3 CMS	3'-5 1/4" X 3'-5 1/2"	2
F	6'-0" X 4'-0"	G64 SLDG	6'-0 1/2" X 4'-0 1/2"	1
G	5'-0" X 3'-6"	G536 SLDG	5'-0 1/2" X 3'-6 1/2"	4
H	4'-0" X 3'-6"	C436 SLDG	4'-0 1/2" X 3'-6 1/2"	1
J	4'-0" X 2'-0"	A41 AWN	4'-0 1/2" X 2'-0 5/8"	1
K	4'-0" X 4'-0"	G42 SLDG	4'-0 1/2" X 4'-0 1/2"	3

DOOR SCHEDULE			
MARK	SIZE	TYPE	QUAN
1	3'-0" X 6'-8"	SC METAL INSULATED	1
2	3'-0" X 6'-8"	SC RP FLUSH METAL INSUL	2
3	2'-8" X 6'-8"	SC	2
4	2'-8" X 6'-8"	HC	6
5	2'-6" X 6'-8"	HC	4
6	2'-6" X 6'-8"	POCKET	1
7	2'-4" X 6'-8"	POCKET	2
8	PR 2'-6" X 6'-8"	HC	1
9	3'-0" X 6'-8"	BIPASS	1
10	3'-6" X 6'-8"	BIFOLD	1
11	3'-0" X 6'-0"	BIFOLD	2
12	3'-0" X 6'-8"	SHATTER PROOF	1
13	6'-0" X 6'-8"	WOOD FRAME TEMP SLDG GL	1
14	9'-0" X 7'-0"	OVERHEAD GARAGE	2

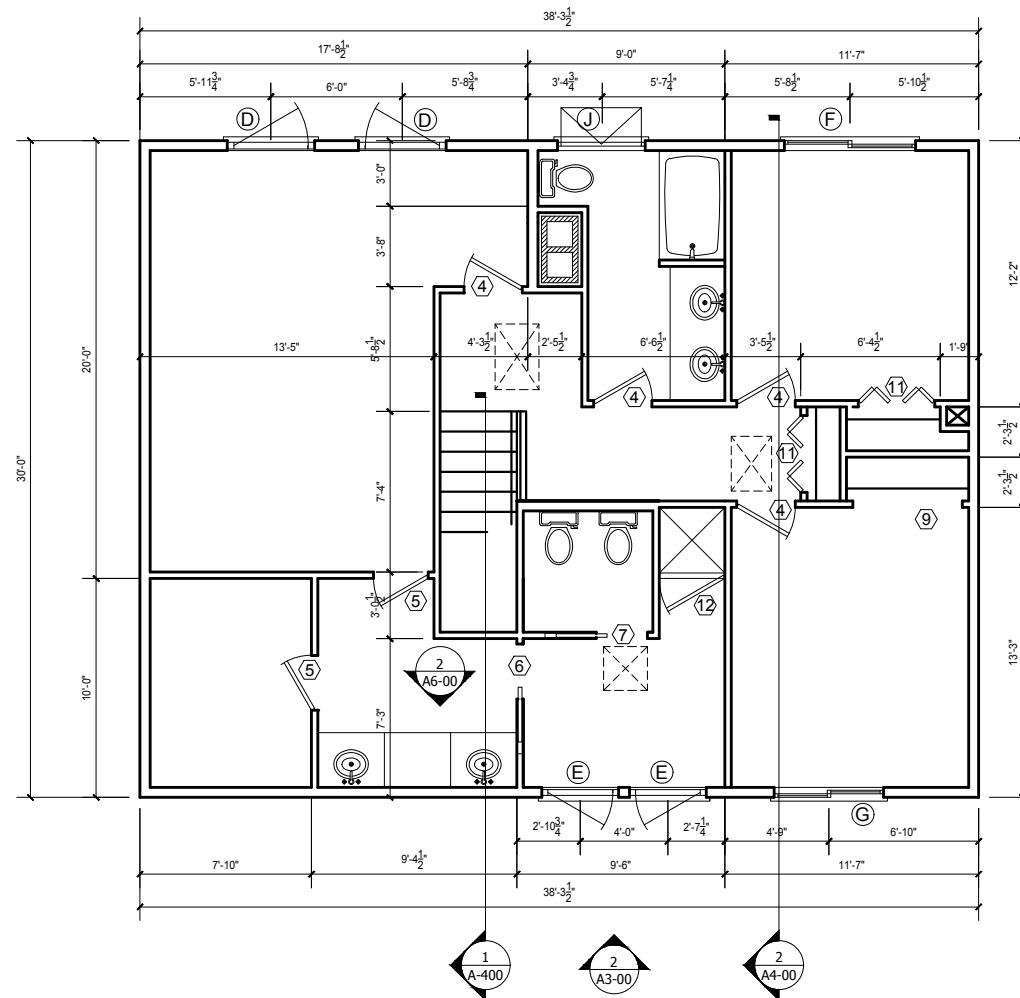

**1** Second Floor Plan  
 Scale: 1/8"=1'-0"

REVISIONS	
DATE	DESCRIPTION

SEAL

DRAWING NAME:  
**FLOOR PLAN**  
 -  
 -

DATE: 12/17/2017 SC: AS SHOWN


DRAWN: NN CHKD:

SHEET NUMBER

**A2-01**



HOUSEPLAN 2101-01  
 1234 RUSTIC  
 HOUSTON, TX 77087

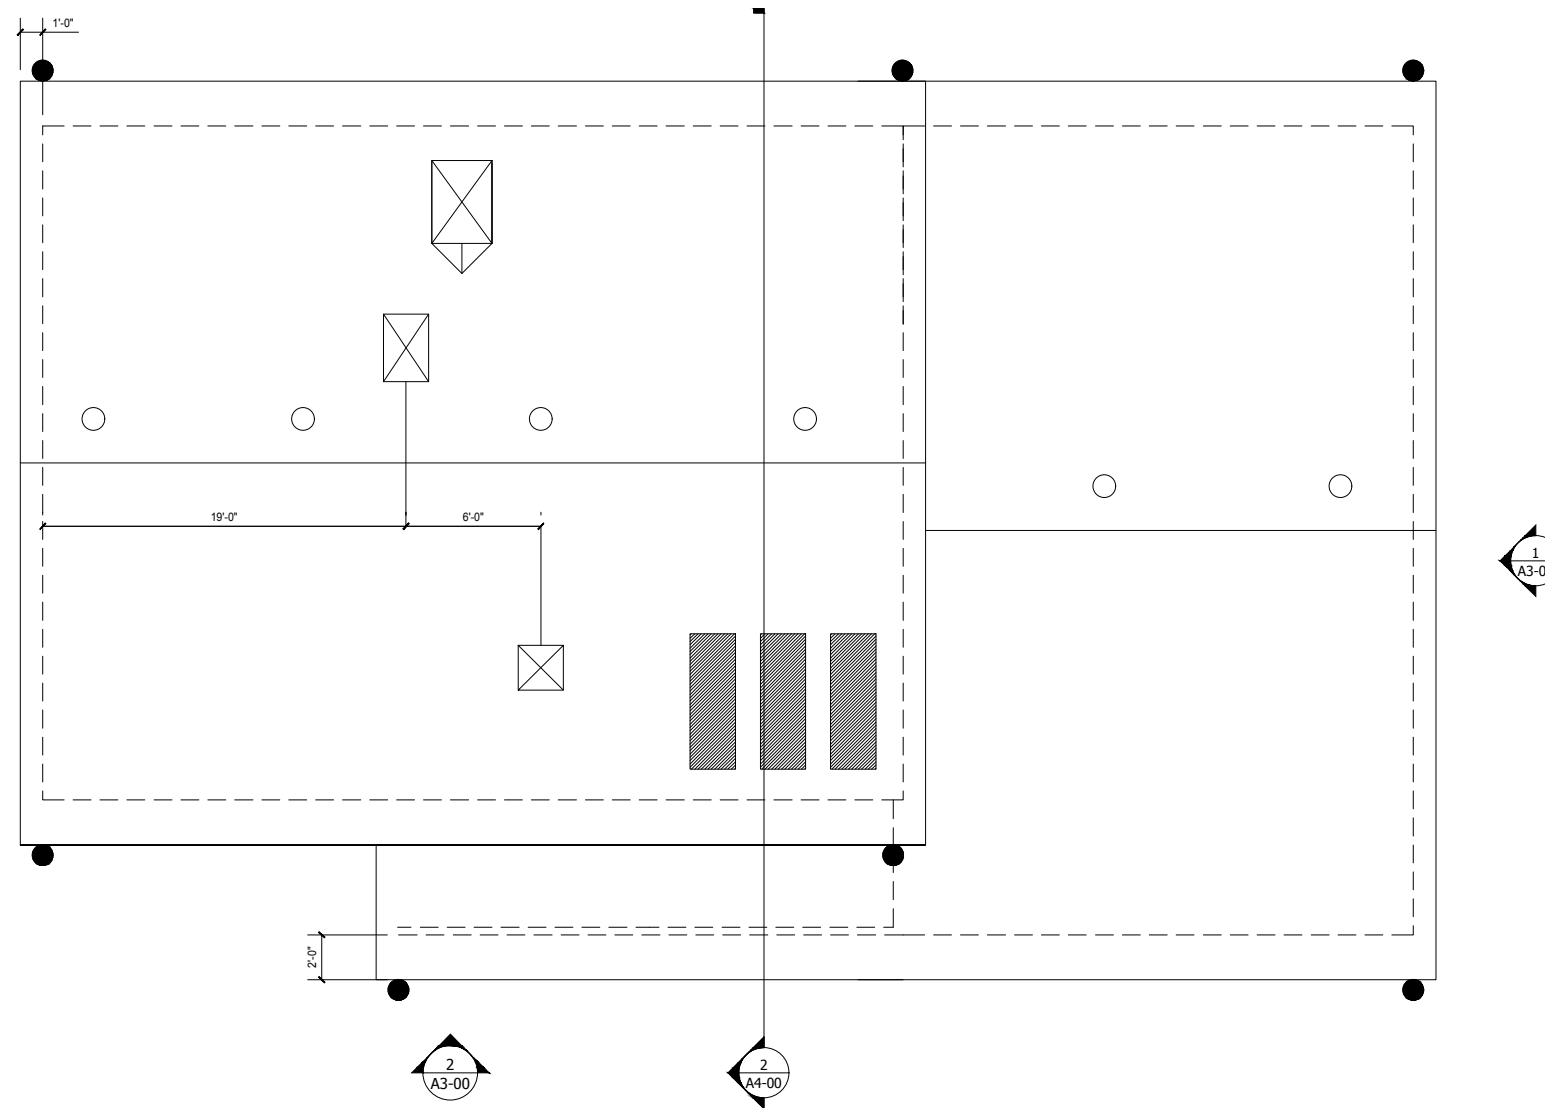

**1** Roof Plan  
 Scale: 1/8"=1'-0"

REVISIONS	
DATE	DESCRIPTION

SEAL

DRAWING NAME:  
**ROOF PLAN**  
 -  
 -

DATE: 12/17/2017	SC: AS SHOWN
DRAWN: NN	CHKD:

SHEET NUMBER  
**A2-02**



HOUSEPLAN 2101-01  
 1234 RUSTIC  
 HOUSTON, TX 77087




**1** Front Elevation  
 Scale: 1/8"=1'-0"




**1** Side Elevation  
 Scale: 1/8"=1'-0"


REVISIONS	
DATE	DESCRIPTION
SEAL	
DRAWING NAME: <b>ELEVATIONS</b>	
-	
-	
DATE: 12/17/2017	SC: AS SHOWN
DRAWN: NN	CHKD:
SHEET NUMBER	
<b>A3-00</b>	

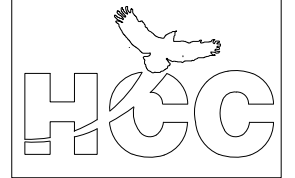

HOUSEPLAN 2101-01  
 1234 RUSTIC  
 HOUSTON, TX 77087

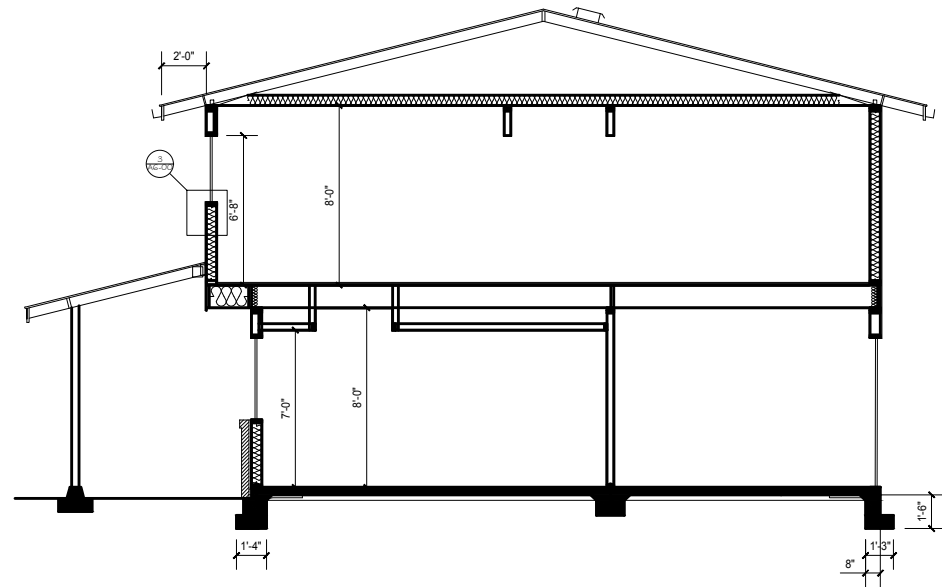

**2** Building Section  
 Scale: 1/8"=1'-0"

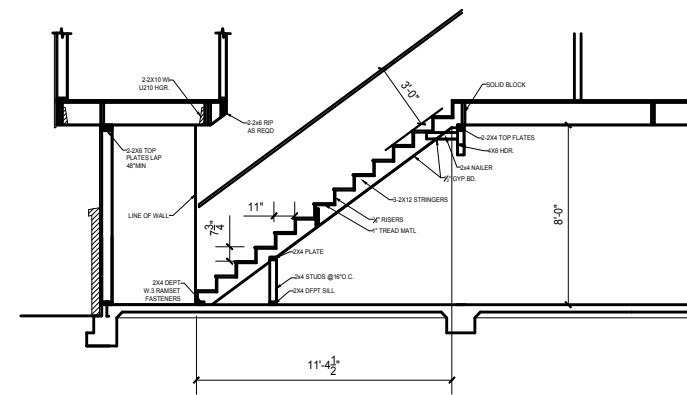

**1** Stair Section  
 Scale: 1/8"=1'-0"

REVISIONS	
DATE	DESCRIPTION

SEAL


DRAWING NAME:  
**Sections**

DATE: 12/17/2017 SC: AS SHOWN  
 DRAWN: NN CHKD:


SHEET NUMBER  
**A4-00**





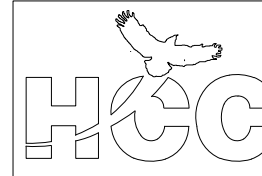

HOUSEPLAN 2101-01  
 1234 RUSTIC  
 HOUSTON, TX 77087

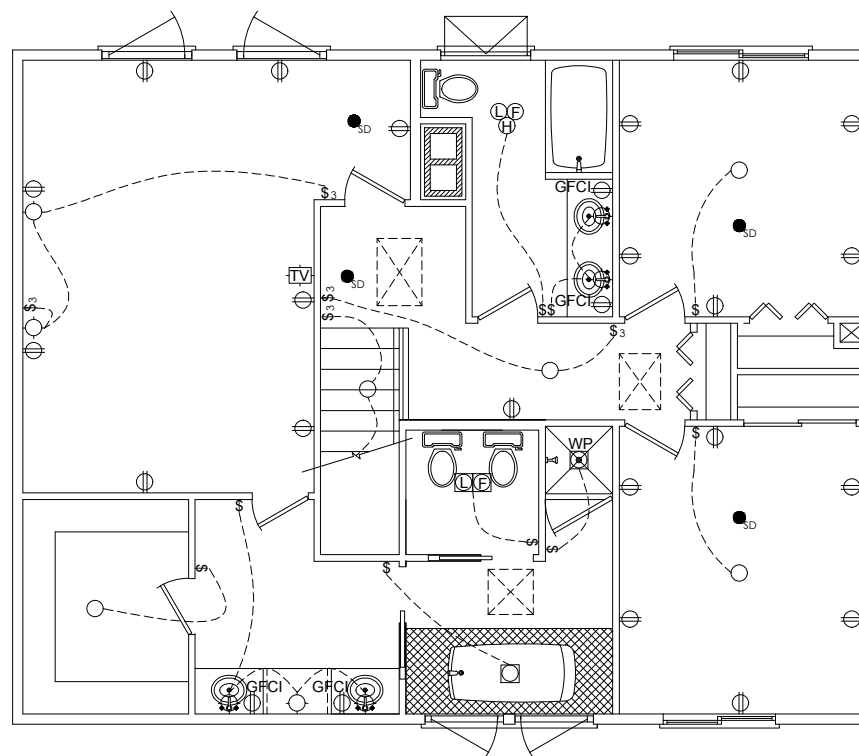

**1** Second Floor Electrical Plan  
 Scale: 1/8"=1'-0"

REVISIONS

DATE	DESCRIPTION

SEAL

DRAWING NAME:


**ELECTRICAL  
 PLAN**

DATE:12/17/2017 SC: AS SHOWN


DRAWN:NN CHKD:

SHEET NUMBER


**A5-01**

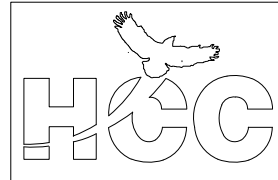


HOUSEPLAN 2101-01  
 1234 RUSTIC  
 HOUSTON, TX 77087

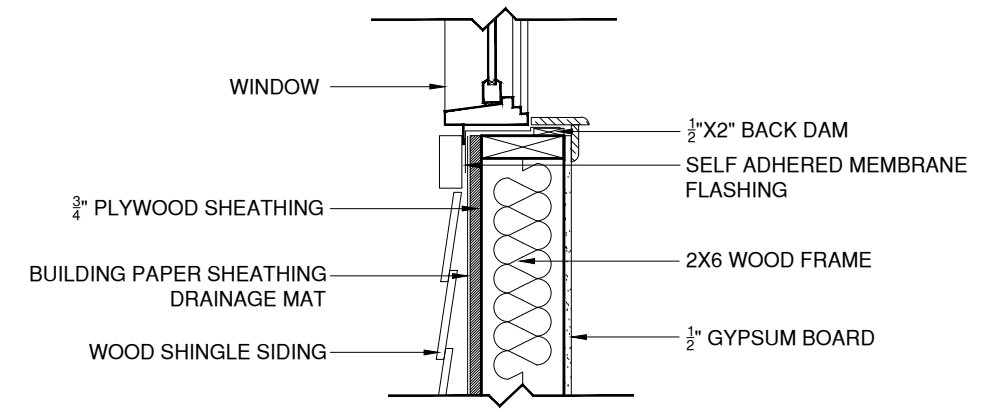

**3** Window Sill Detail  
 Scale: 1"=1'-0"

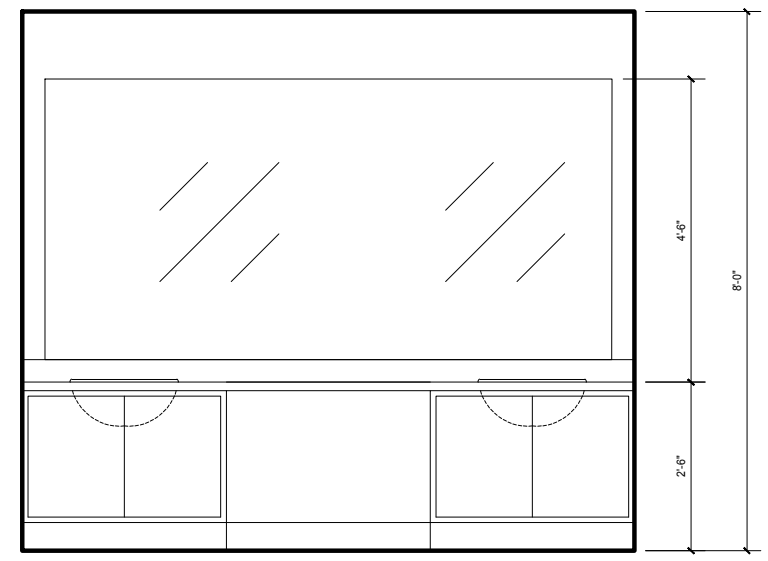

**2** Bathroom Interior Elevation  
 Scale: 3/8"=1'-0"

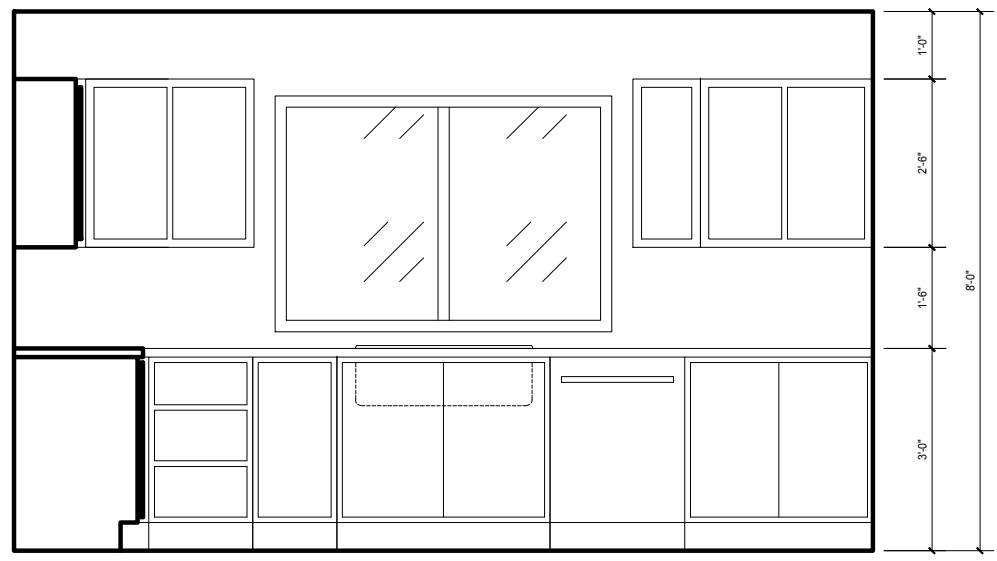

**1** Kitchen Interior Elevation  
 Scale: 3/8"=1'-0"

REVISIONS	
DATE	DESCRIPTION

SEAL

DRAWING NAME:  
**INTERIOR ELEVATIONS & DETAILS**

DATE: 12/17/2017 SC: AS SHOWN  
 DRAWN: NN CHKD:  

SHEET NUMBER  
**A6-00**